


Please goto <http://www.autodwg.com> to register the program, the note will be removed.

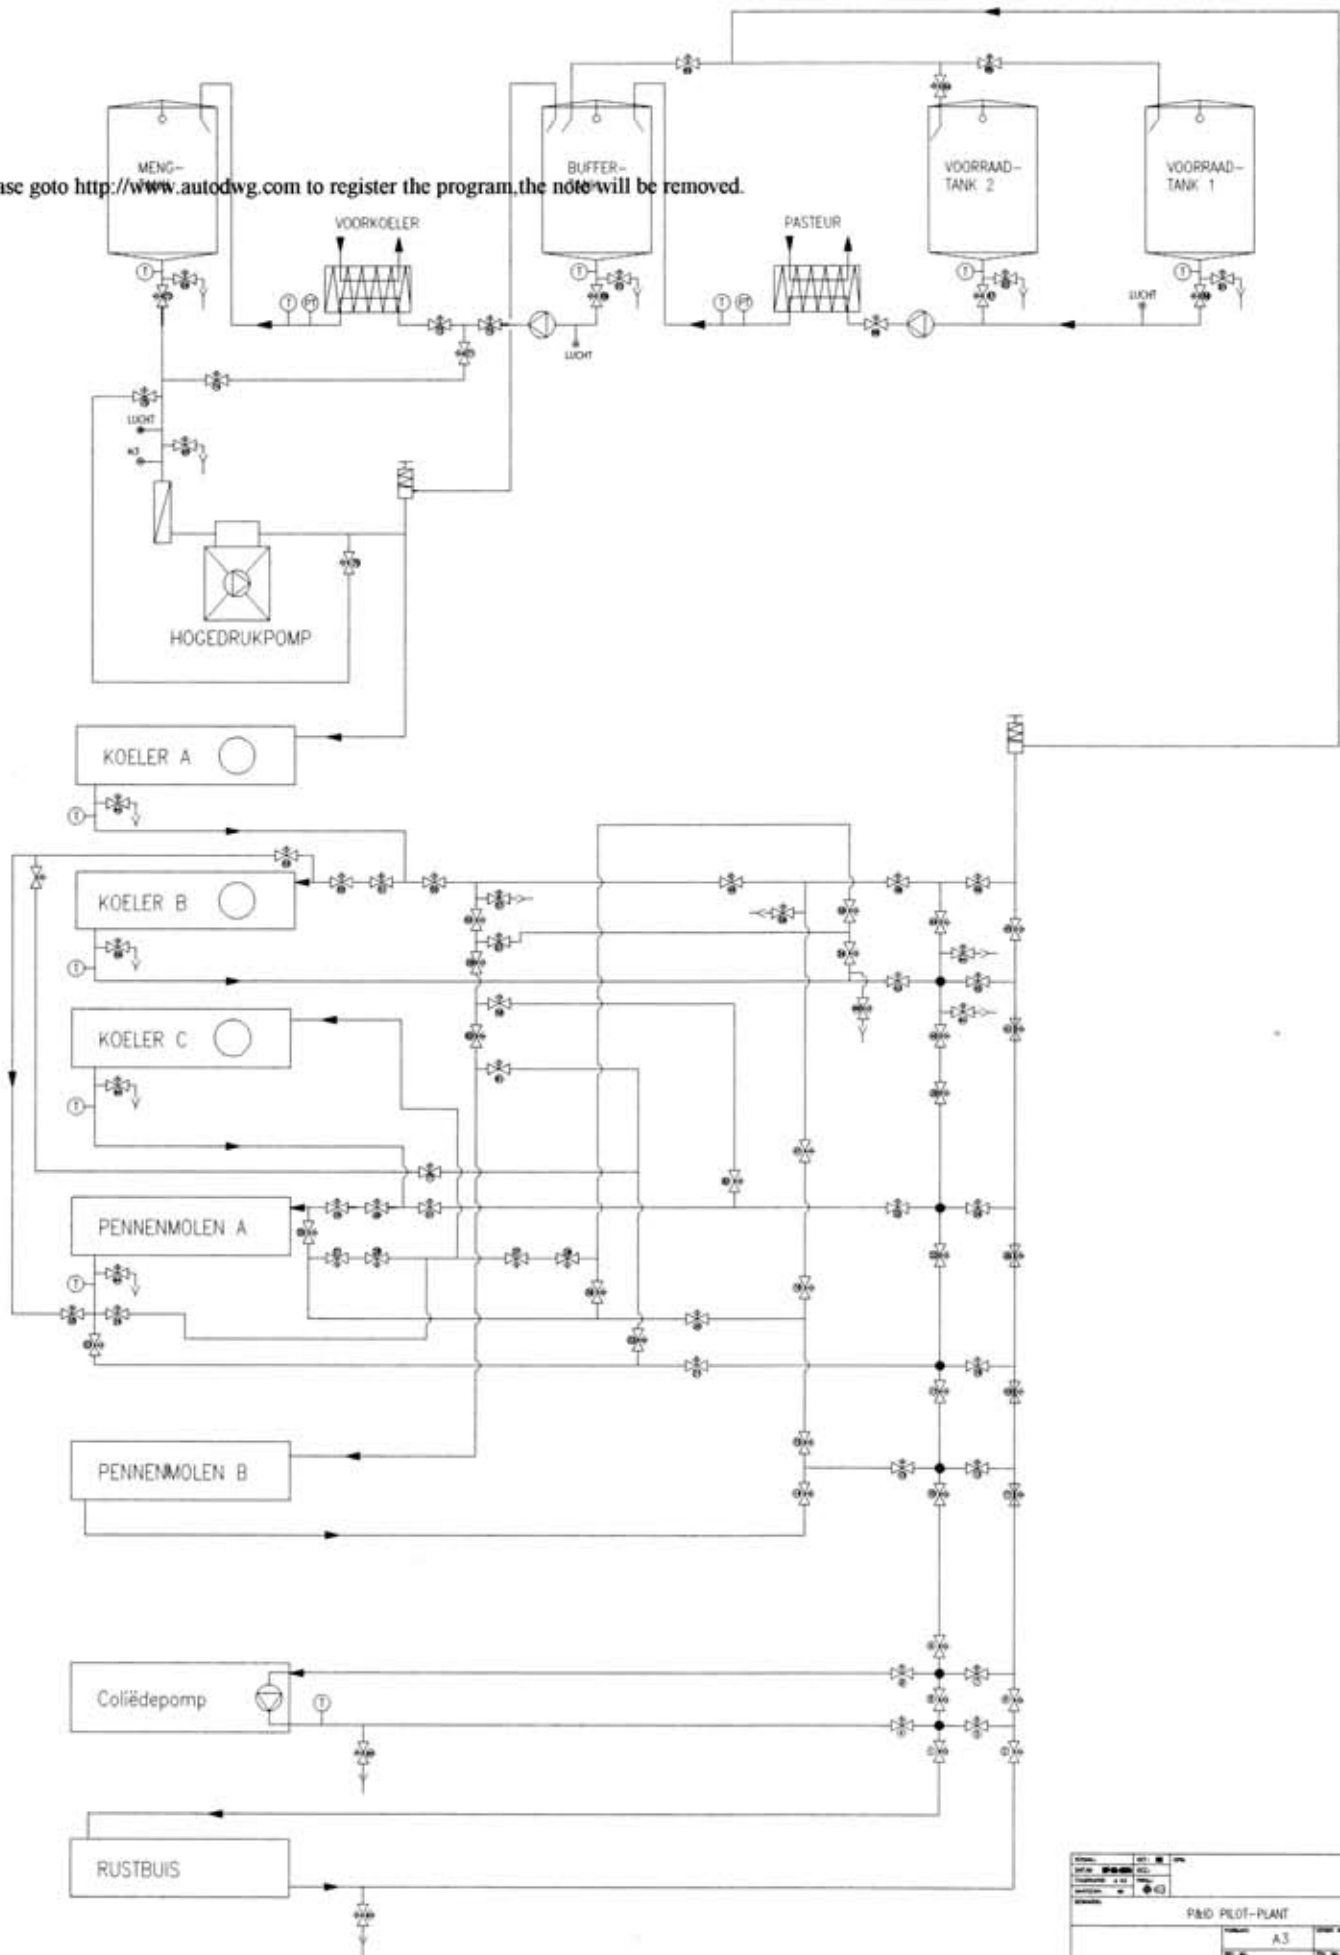

P&ID PLOT-PLAN		
Scale	A3	5112701
Sheet No.	2130	