


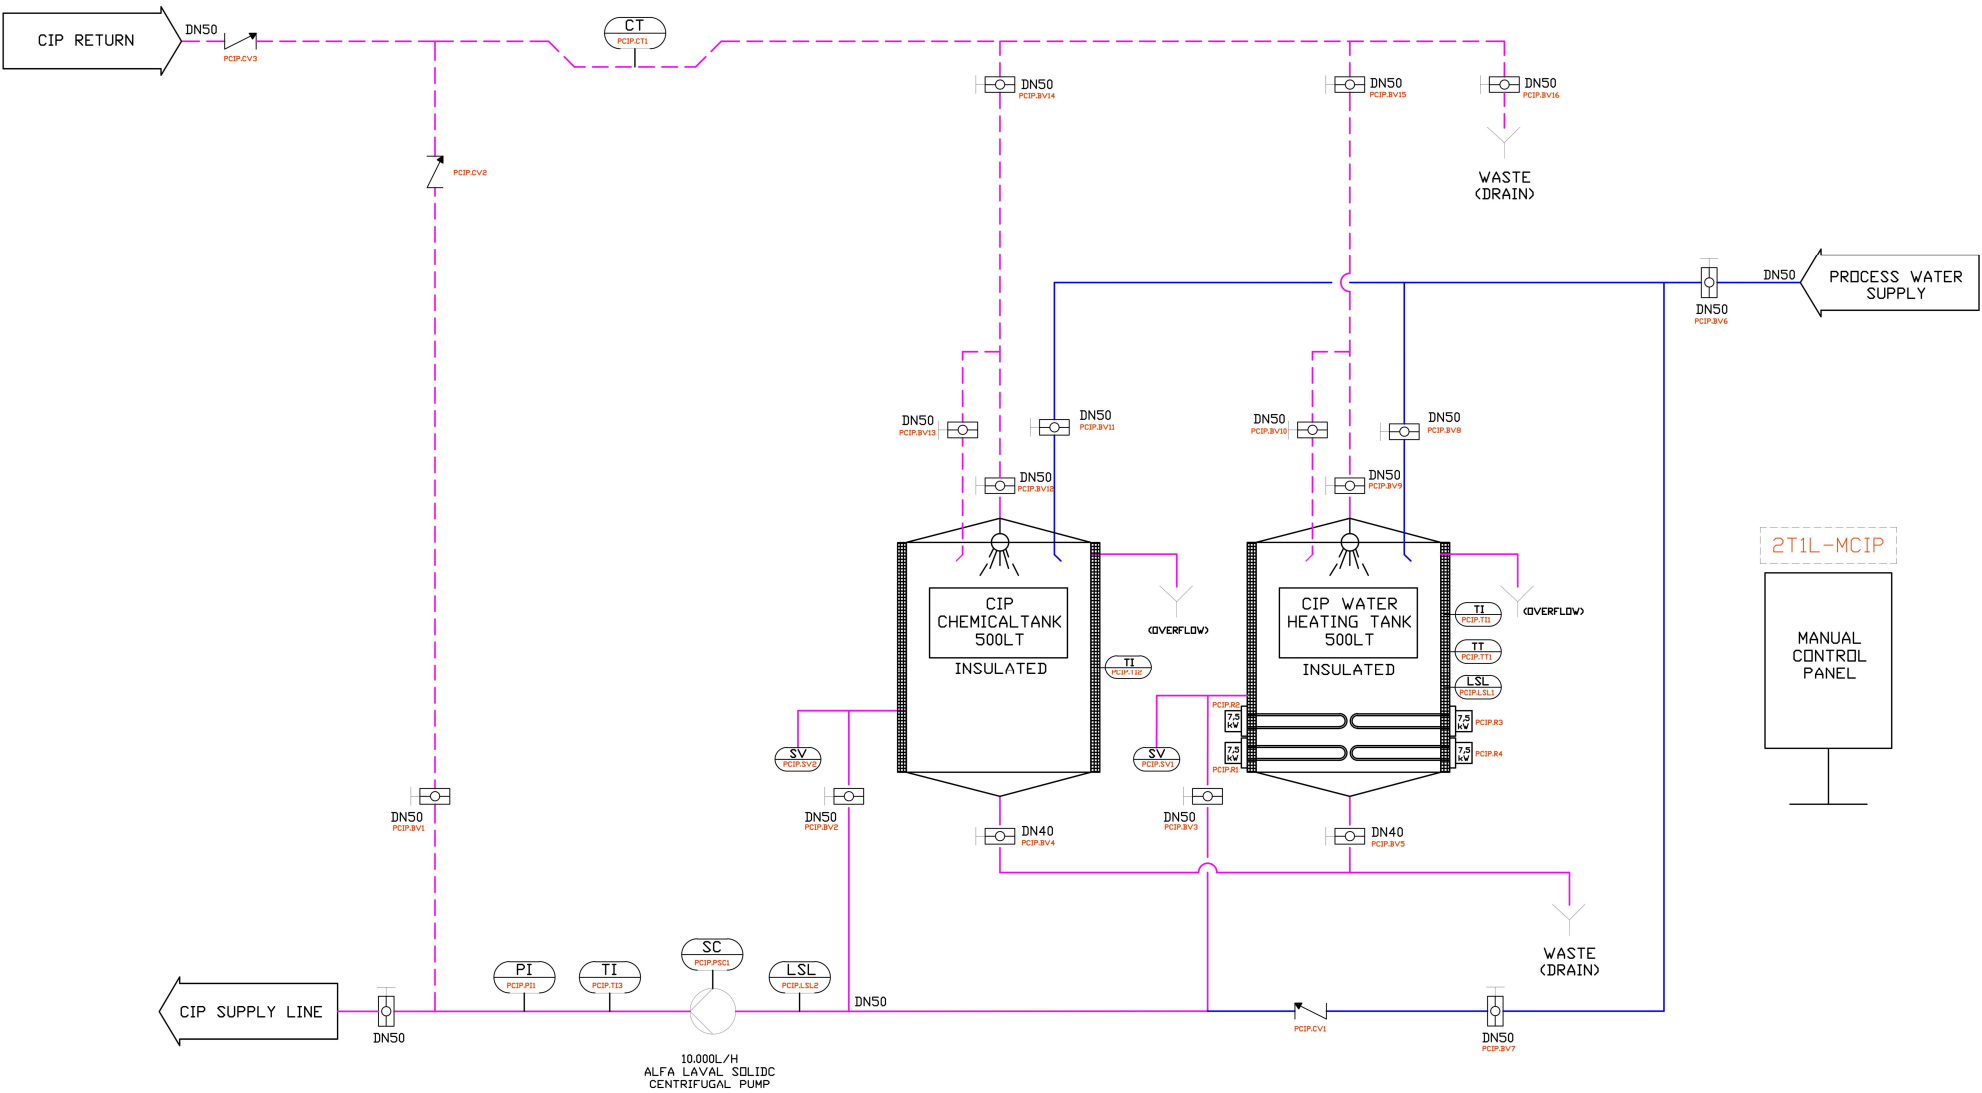

P&ID SYMBOLS
EXPLANATION

	CIP SUPPLY LINE
	CIP CIRCULATION LINE
	PROCESS WATER SUPPLY
	CHECK VALVE (NON-RETURN)
	MANUAL BUTTERFLY VALVE
	CENTRIFUGAL PUMP
	TEMPERATURE INDICATOR
	TEMPERATURE TRANSMITTER
	PRESSURE INDICATOR
	LEVEL SENSOR LOW
	CONDUCTIVITY TRANSMITTER
	SPEED CONTROL
	SAMPLING VALVE
	ELECTRICAL RESISTANCE

2x 500L TANK MANUAL CIP SYSTEM - P&ID DRAWING

PROJECT NAME	2x 500L TANK MANUAL CIP SYSTEM	CUSTOMER		
MATERIAL	AISI 316L Cr/Ni 2B FINISH			
DRAWN BY.		QTY.	1	
CONTROLLED BY.		PROJECT NO	PD-0120-24	
APPROVED BY.				
DATE	15.01.2025			